


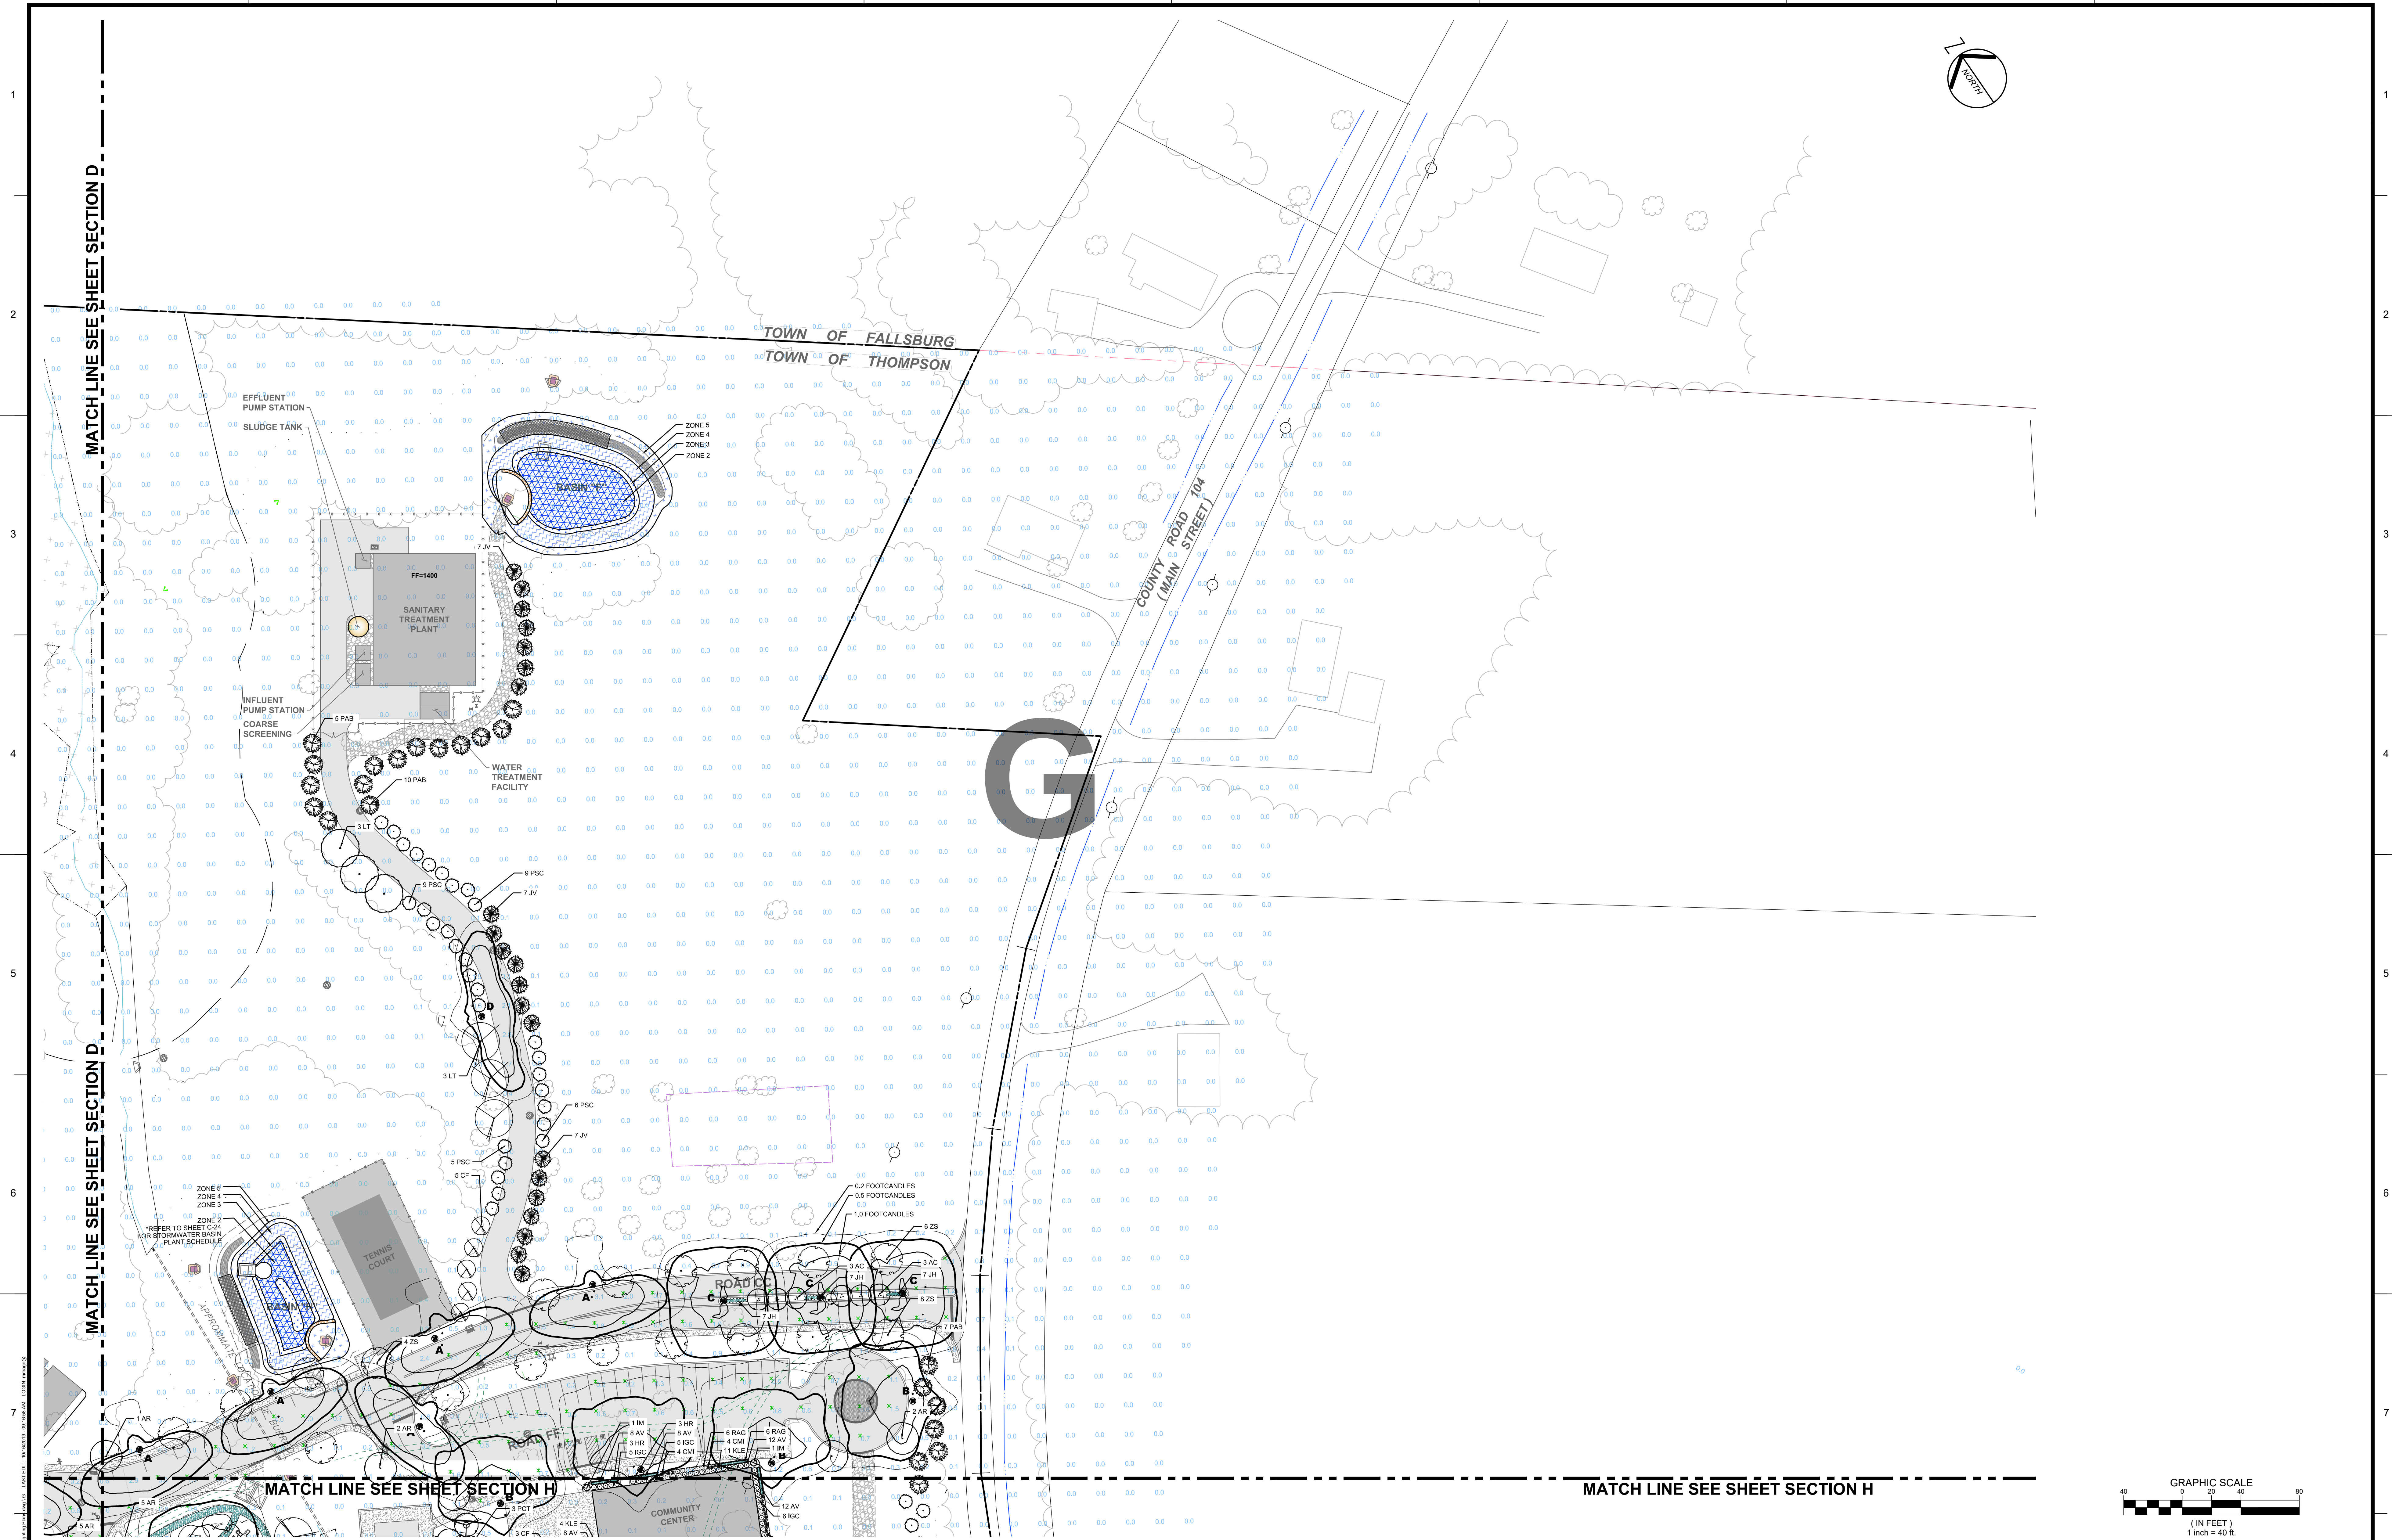

IN WITNESS WHEREOF, NYS Education Law, Article 145 Section 7200(2), for any person, unless he is acting under the direction of a licensed professional engineer or land surveyor, shall not be deemed to be a duly authorized signature and the date of the alteration shall be deemed to be the date of the signature and the date of the alteration, and a specific description of the alteration.


ALL DIMENSIONS MUST BE VERIFIED BY THE CONTRACTOR, NOTED PAULUS, SKOLINSKI, AND SARTOR OF ANY CONFLICTS, ERRORS, AMBIGUITIES OR DISCREPANCIES IN THE DRAWINGS AND NOT BE DEPENDENT ON ANY OTHER DOCUMENTS.

ALL DIMENSIONS SHALL BE AS NOTED IN WORDS OR NUMBERS ON THE CONTRACT DRAWINGS, DO NOT SCALE THE DRAWINGS TO DETERMINE DIMENSIONS.

THESE CONTRACT DRAWINGS CONTAIN DATA INTRODUCED SPECIFICALLY FOR THE NOTED PROJECT AND NOT BE USED FOR ANY OTHER PROJECT OR FOR ANY OTHER PROJECT OR FOR REUSE ON ANY OTHER PROJECT.

COPIING AND REUSE OF ANY OF THESE DOCUMENTS OR ANY PART THEREOF WITHOUT THE WRITTEN PERMISSION OF PAULUS, SKOLINSKI, AND SARTOR IS PROHIBITED.

COPYRIGHT 1998 PAULUS, SKOLINSKI, AND SARTOR - ALL RIGHTS RESERVED.

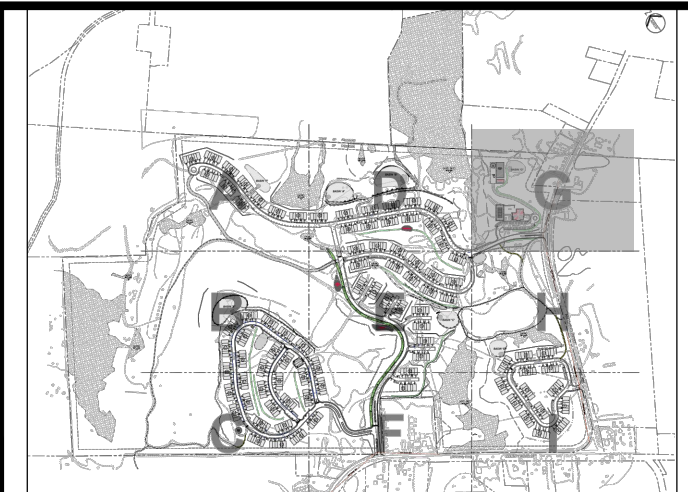

CONSULTANTS

PS&S
integrating design & engineering

67A MOUNTAIN BOULEVARD EXTENSION
P.O. BOX 4039
WARREN, NEW JERSEY 07059
PHONE: (732) 560-9700
FAX: (732) 560-9768

LISA A. DIGEROLAMO, P.E.
PROFESSIONAL ENGINEER
NEW YORK LIC. NO. 086749

[illegible]

PROJECT TITLE

PRELIMINARY & FINAL SITE PLAN

Gan-Eden Estates

TOWN OF THOMPSON SULLIVAN COUNTY NEW YORK

TAX LOT
SECTION 2,
BLOCK 1/ LOT 6.3

SHEET TITLE

**LANDSCAPE AND
LIGHTING PLAN**
(SECTION G)

INITIAL DATE	JOB NO.
OCT. 15, 2019	01895.0053
SCALE	B/O
1" = 40'	
DRAWN	SHEET NO.
C.Y. / F.M.	C-07G
CHKD.	
L.A.D.	42 OF 103