


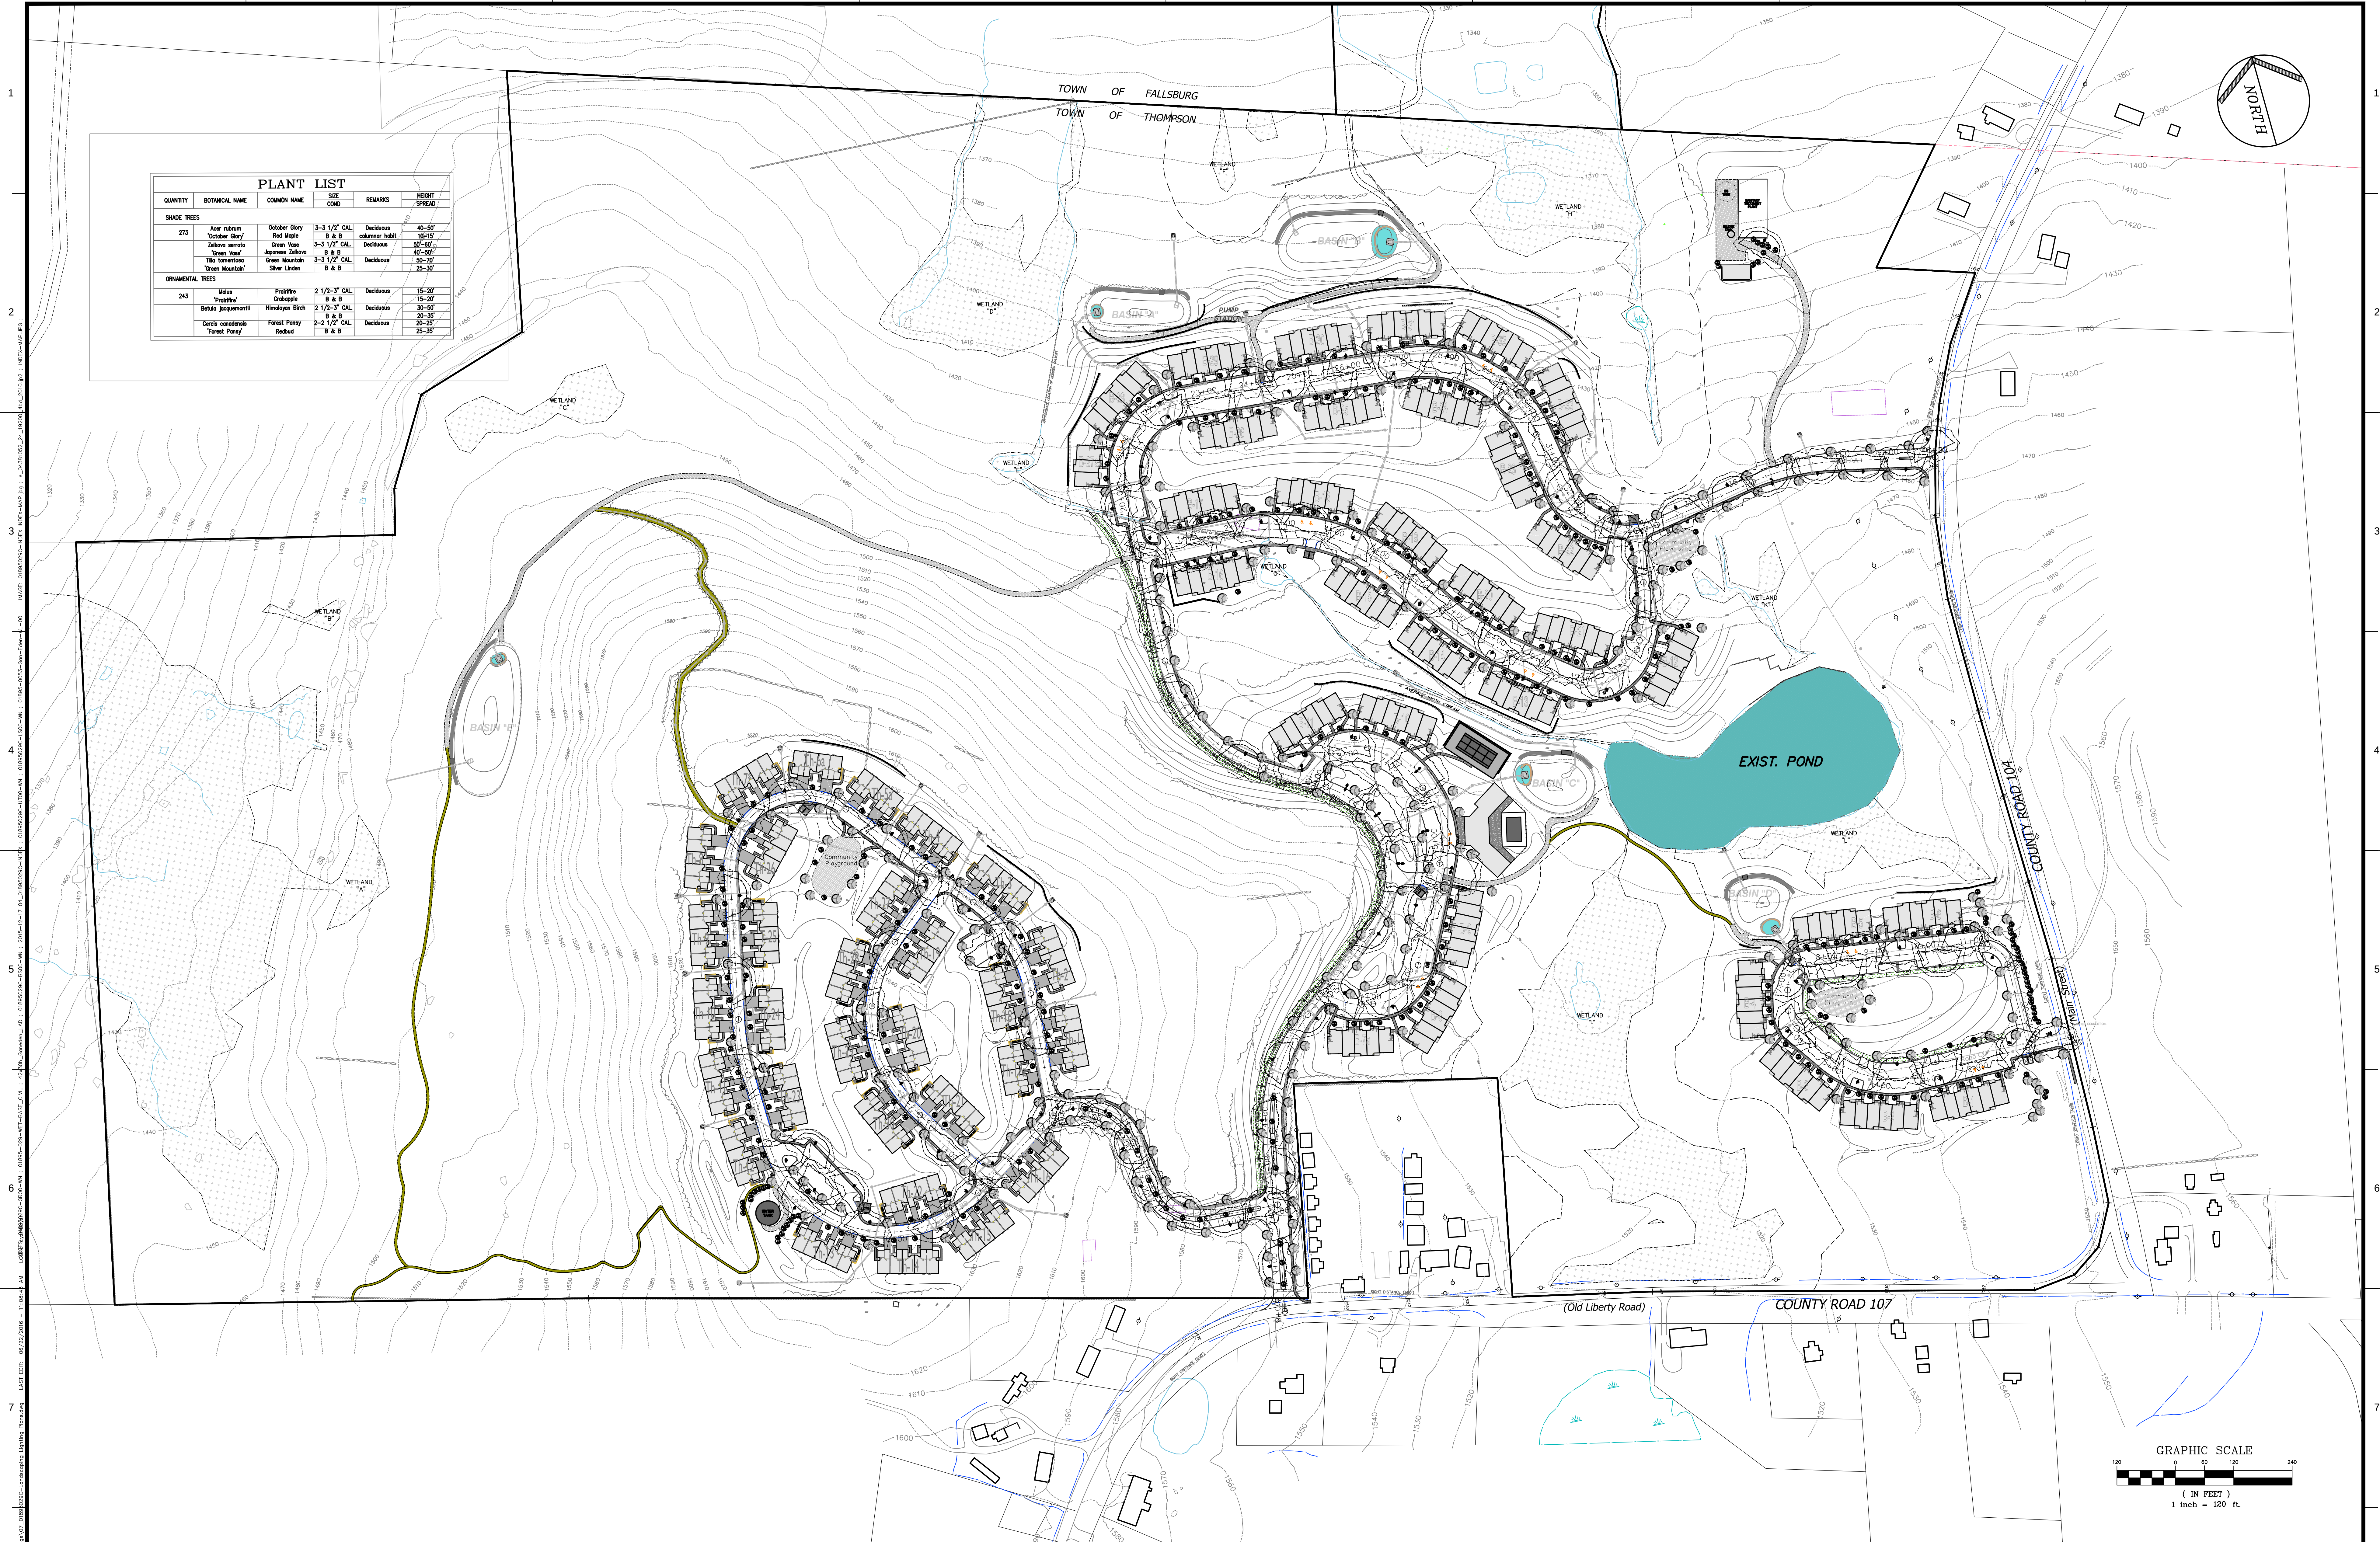

PLANT LIST						
QUANTITY	BOTANICAL NAME	COMMON NAME	SIZE	REMARKS	HEIGHT	SPREAD
SHADE TREES						
275	Acer rubrum	October Glory	3-3 1/2" CAL.	Deciduous	40-50'	
	Red Maple		B & B	columnar habit	100-120'	
	Zelkova serrata	Green Vase	3-3 1/2" CAL.	Deciduous	50'-60'	
	Japanese Zelkova		B & B		40-50'	
	Hicoria tomentosa	Green Mountain	3-3 1/2" CAL.	Deciduous	50-70'	
245	Green Mountain	Silver Linden	B & B		25-30'	
	Prunifera	Crabapple	2 1/2-3" CAL.	Deciduous	15-20'	
	Hemlock Birch		B & B		15-20'	
	Betula jacquemontii		B & B		20-30'	
	Cercis canadensis	Forest Pansy	2-2 1/2" CAL.	Deciduous	20-25'	
245	Forest Pansy	Redbud	B & B		25-30'	

PS&S
integrating design & engineering

67A MOUNTAIN BOULEVARD EXTENSION
P.O. BOX 4039
WARREN, NEW JERSEY 07059
PHONE: (732) 560-9700
FAX: (732) 560-9768

LISA A. DIGEROLAMO, P.E.
PROFESSIONAL ENGINEER
NEW YORK LIC. NO. 086749

SIGNATURE _____ DATE 7/1/2016

REV	DATE	DESCRIPTION
02/10/16	02/10/16	PRE-ISSUE FOR TEAM REVIEW
05/11/16	05/11/16	PRELIMINARY SITE PLAN REVIEW
07/5/16	07/5/16	SUBMISSION TO PLANNING BOARD

PROJECT TITLE

PRELIMINARY & FINAL SITE PLAN

Gan-Eden Estates

TOWN OF THOMPSON SULLIVAN COUNTY NEW YORK

SHEET TITLE

TAX LOT SECTION 2, BLOCK 1/ LOT 6.3

Overall Landscaping & Lighting Plan

INITIAL DATE 12/04/2015

SCALE 1"=120'

DRAWN CY/FM

CHKD. AG/LAD

JOB NO. 01895/0053

B/O

SHEET NO. C-7

31 OF 79