
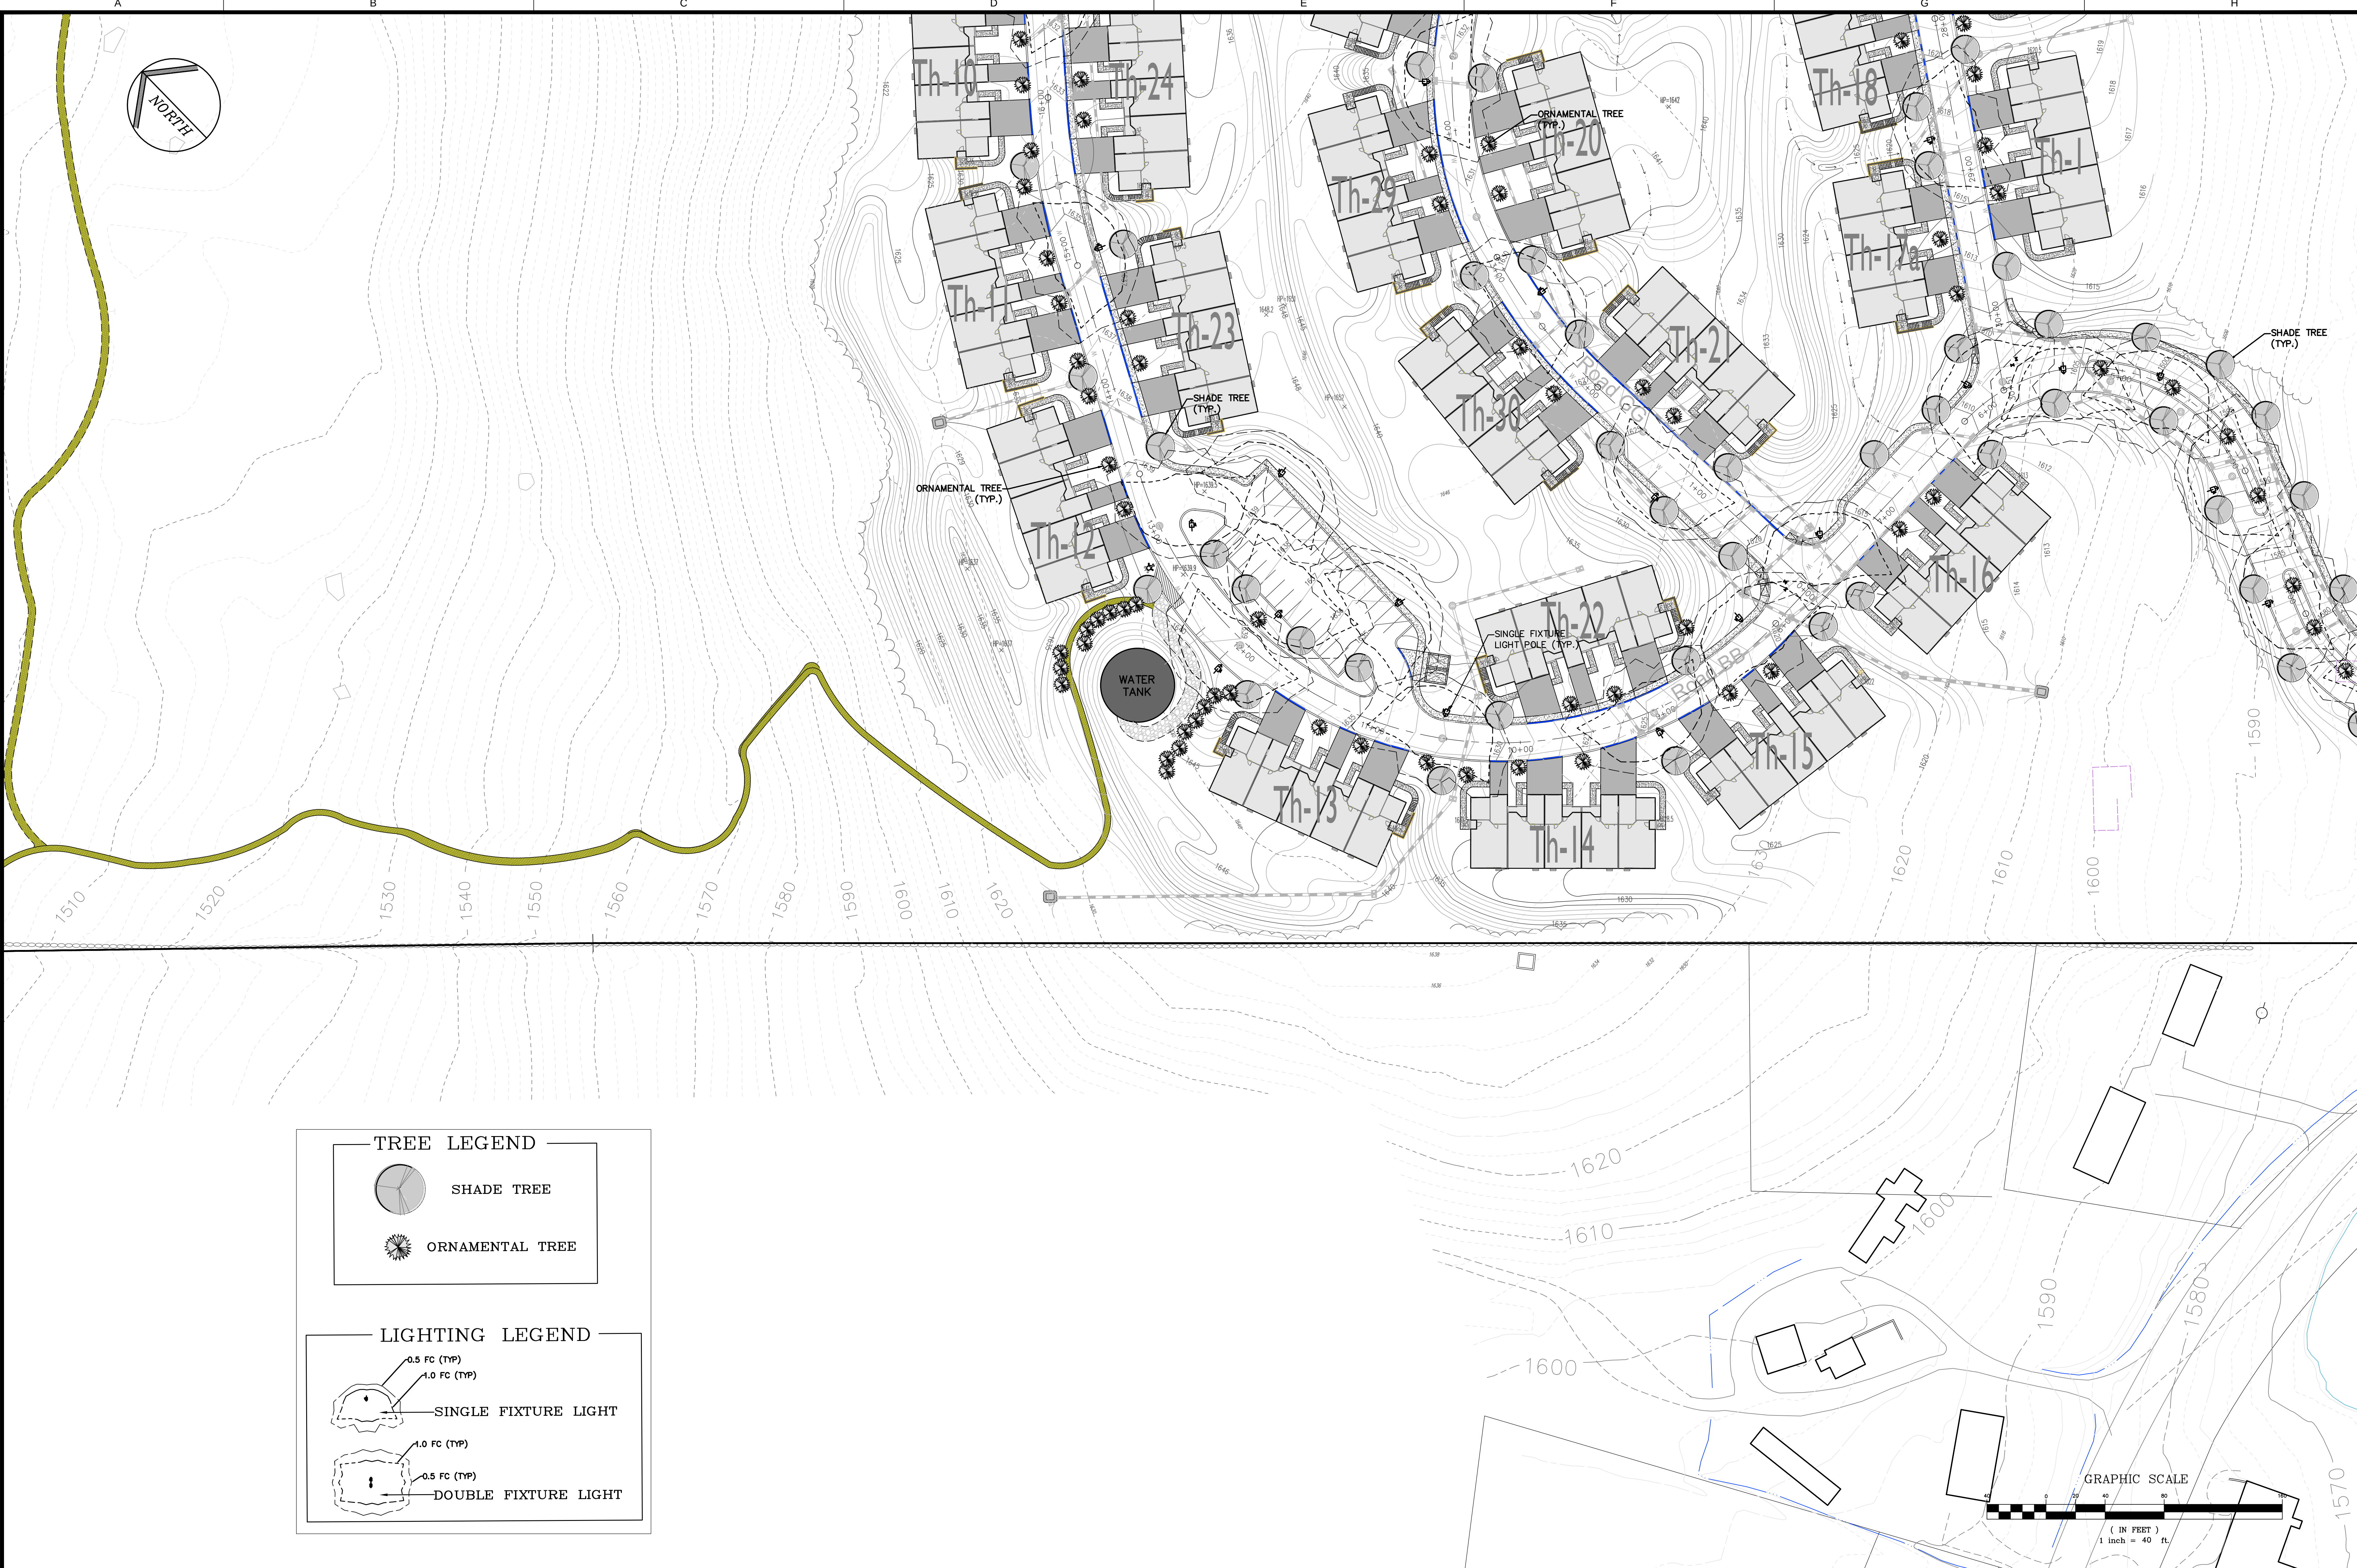
 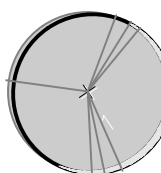






TREE LEGEND


 SHADE TREE

 ORNAMENTAL TREE

LIGHTING LEGEND

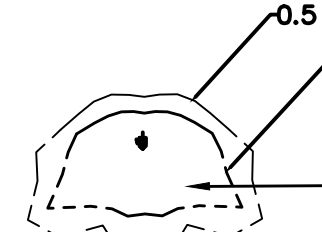 0.5 FC (TYP)
1.0 FC (TYP)
SINGLE FIXTURE LIGHT

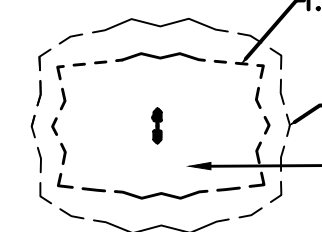 1.0 FC (TYP)
0.5 FC (TYP)
DOUBLE FIXTURE LIGHT

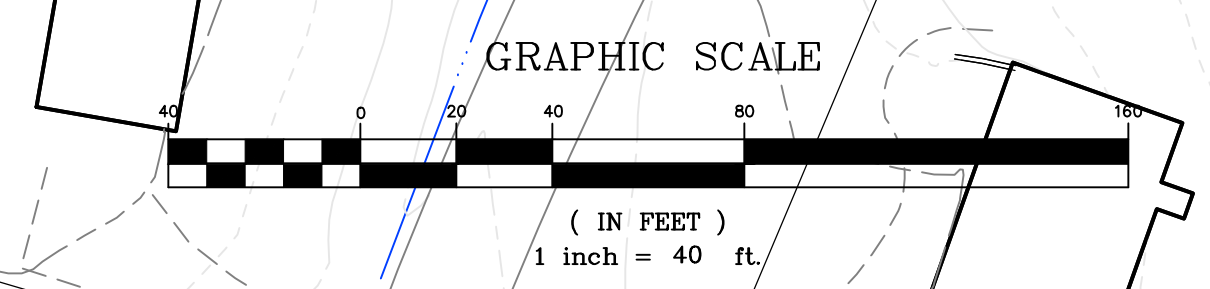


It is a violation of NYS Education Law, Article 145 Section 7208(2), for any person, unless he is acting under the direction of a duly licensed professional engineer or architect, to prepare, or cause to be prepared, any drawing, plan, map, or other document for use in connection with the construction of any building, structure, or other work, which drawing, plan, map, or other document is required by law to be signed and sealed by a duly licensed professional engineer or architect, and which drawing, plan, map, or other document is so signed and sealed, and which drawing, plan, map, or other document is used in connection with the construction of any building, structure, or other work, without the written permission of the duly licensed professional engineer or architect who has signed and sealed the drawing, plan, map, or other document.

ALL DIMENSIONS MUST BE NOTED BY THE CONTRACTOR. NOTIFY PAULUS, SOKOLOWSKI AND PARTNERS OF ANY DISCREPANCIES, ERRORS, OMISSIONS, OR DISCREPANCIES IN THE CONTRACT DRAWINGS. DO NOT SCALE THE DRAWINGS TO DETERMINE DIMENSIONS.

THESE CONTRACT DRAWINGS CONTAIN DATA INTENDED SPECIFICALLY FOR THE NOTED PROJECT AND CLIENT. THEY ARE NOT INTENDED FOR USE ON EXTENSIONS OF THIS PROJECT OR FOR REUSE ON ANY OTHER PROJECT.

THE COPYING AND/OR MODIFICATION OF THIS DOCUMENT OR ANY PORTION THEREOF WITHOUT THE WRITTEN PERMISSION OF PAULUS, SOKOLOWSKI AND PARTNERS IS PROHIBITED.

COPYRIGHT 2016 PAULUS, SOKOLOWSKI AND PARTNERS - ALL RIGHTS RESERVED.

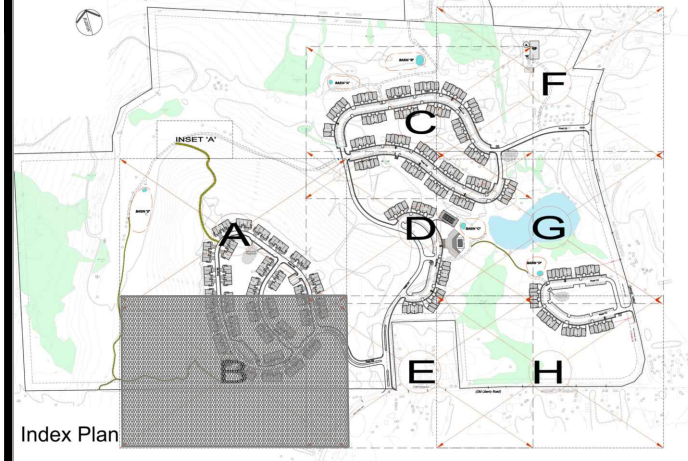

CONSULTANTS

PS&S
integrating design & engineering

67A MOUNTAIN BOULEVARD EXTENSION
P.O. BOX 4039
WARREN, NEW JERSEY 07059
PHONE: (732) 560-9700
FAX: (732) 560-9768

LISA A. DIGEROLAMO, P.E.
PROFESSIONAL ENGINEER
NEW YORK LIC. NO. 086749

SIGNATURE _____ DATE 7/1/2016

REVISIONS/ISSUES		
REV	DATE	DESCRIPTION
1	02/10/16	PRE-ISSUE FOR TEAM REVIEW
2	05/11/16	PRELIMINARY SITE PLAN REVIEW
3	07/5/16	SUBMISSION TO PLANNING BOARD

PROJECT TITLE

PRELIMINARY & FINAL SITE PLAN

Gan-Eden Estates

TOWN OF THOMPSON SULLIVAN COUNTY NEW YORK

TAX LOT SECTION 2, BLOCK 1/ LOT 6.3

SHEET TITLE		INITIAL DATE	JOB NO.
Landscaping & Lighting Plan (Section B)		12/04/2015	01895/0053
		SCALE	B/O
		1"=40'	
		DRAWN	CY/FM
CHKD.		AG/LAD	SHEET NO.
			C-7B
			33 OF 79