


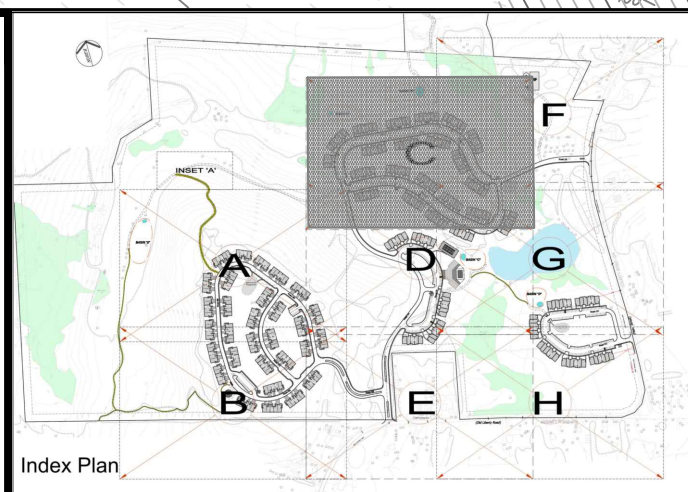

GRAPHIC SCALE

(IN FEET)
1 inch = 40 ft.



CONSULTANTS

PS&S
integrating design & engineering

67A MOUNTAIN BOULEVARD EXTENSION
P.O. BOX 4039
WARREN, NEW JERSEY 07059
PHONE: (732) 560-9700
FAX: (732) 560-9768

LISA A. DIGEROLAMO, P.E.
PROFESSIONAL ENGINEER
NEW YORK LIC. NO. 086749

SIGNATURE DATE 7/1/2016

[illegible]

PROJECT TITLE

PRELIMINARY & FINAL SITE PLAN

Gan-Eden Estates

TOWN OF THOMPSON SULLIVAN COUNTY NEW YORK

TAX LOT
SECTION 2,
BLOCK 1/ LOT 6.3

SHEET TITLE Landscaping & Lighting Plan (Section C)	INITIAL DATE 12/04/2015	JOB NO. 01895/0053
	SCALE 1"=40'	B/O 8
	DRAWN CY/FM	SHEET NO. C-7C 34 OF 79
	CHKD. AG/LAD	