



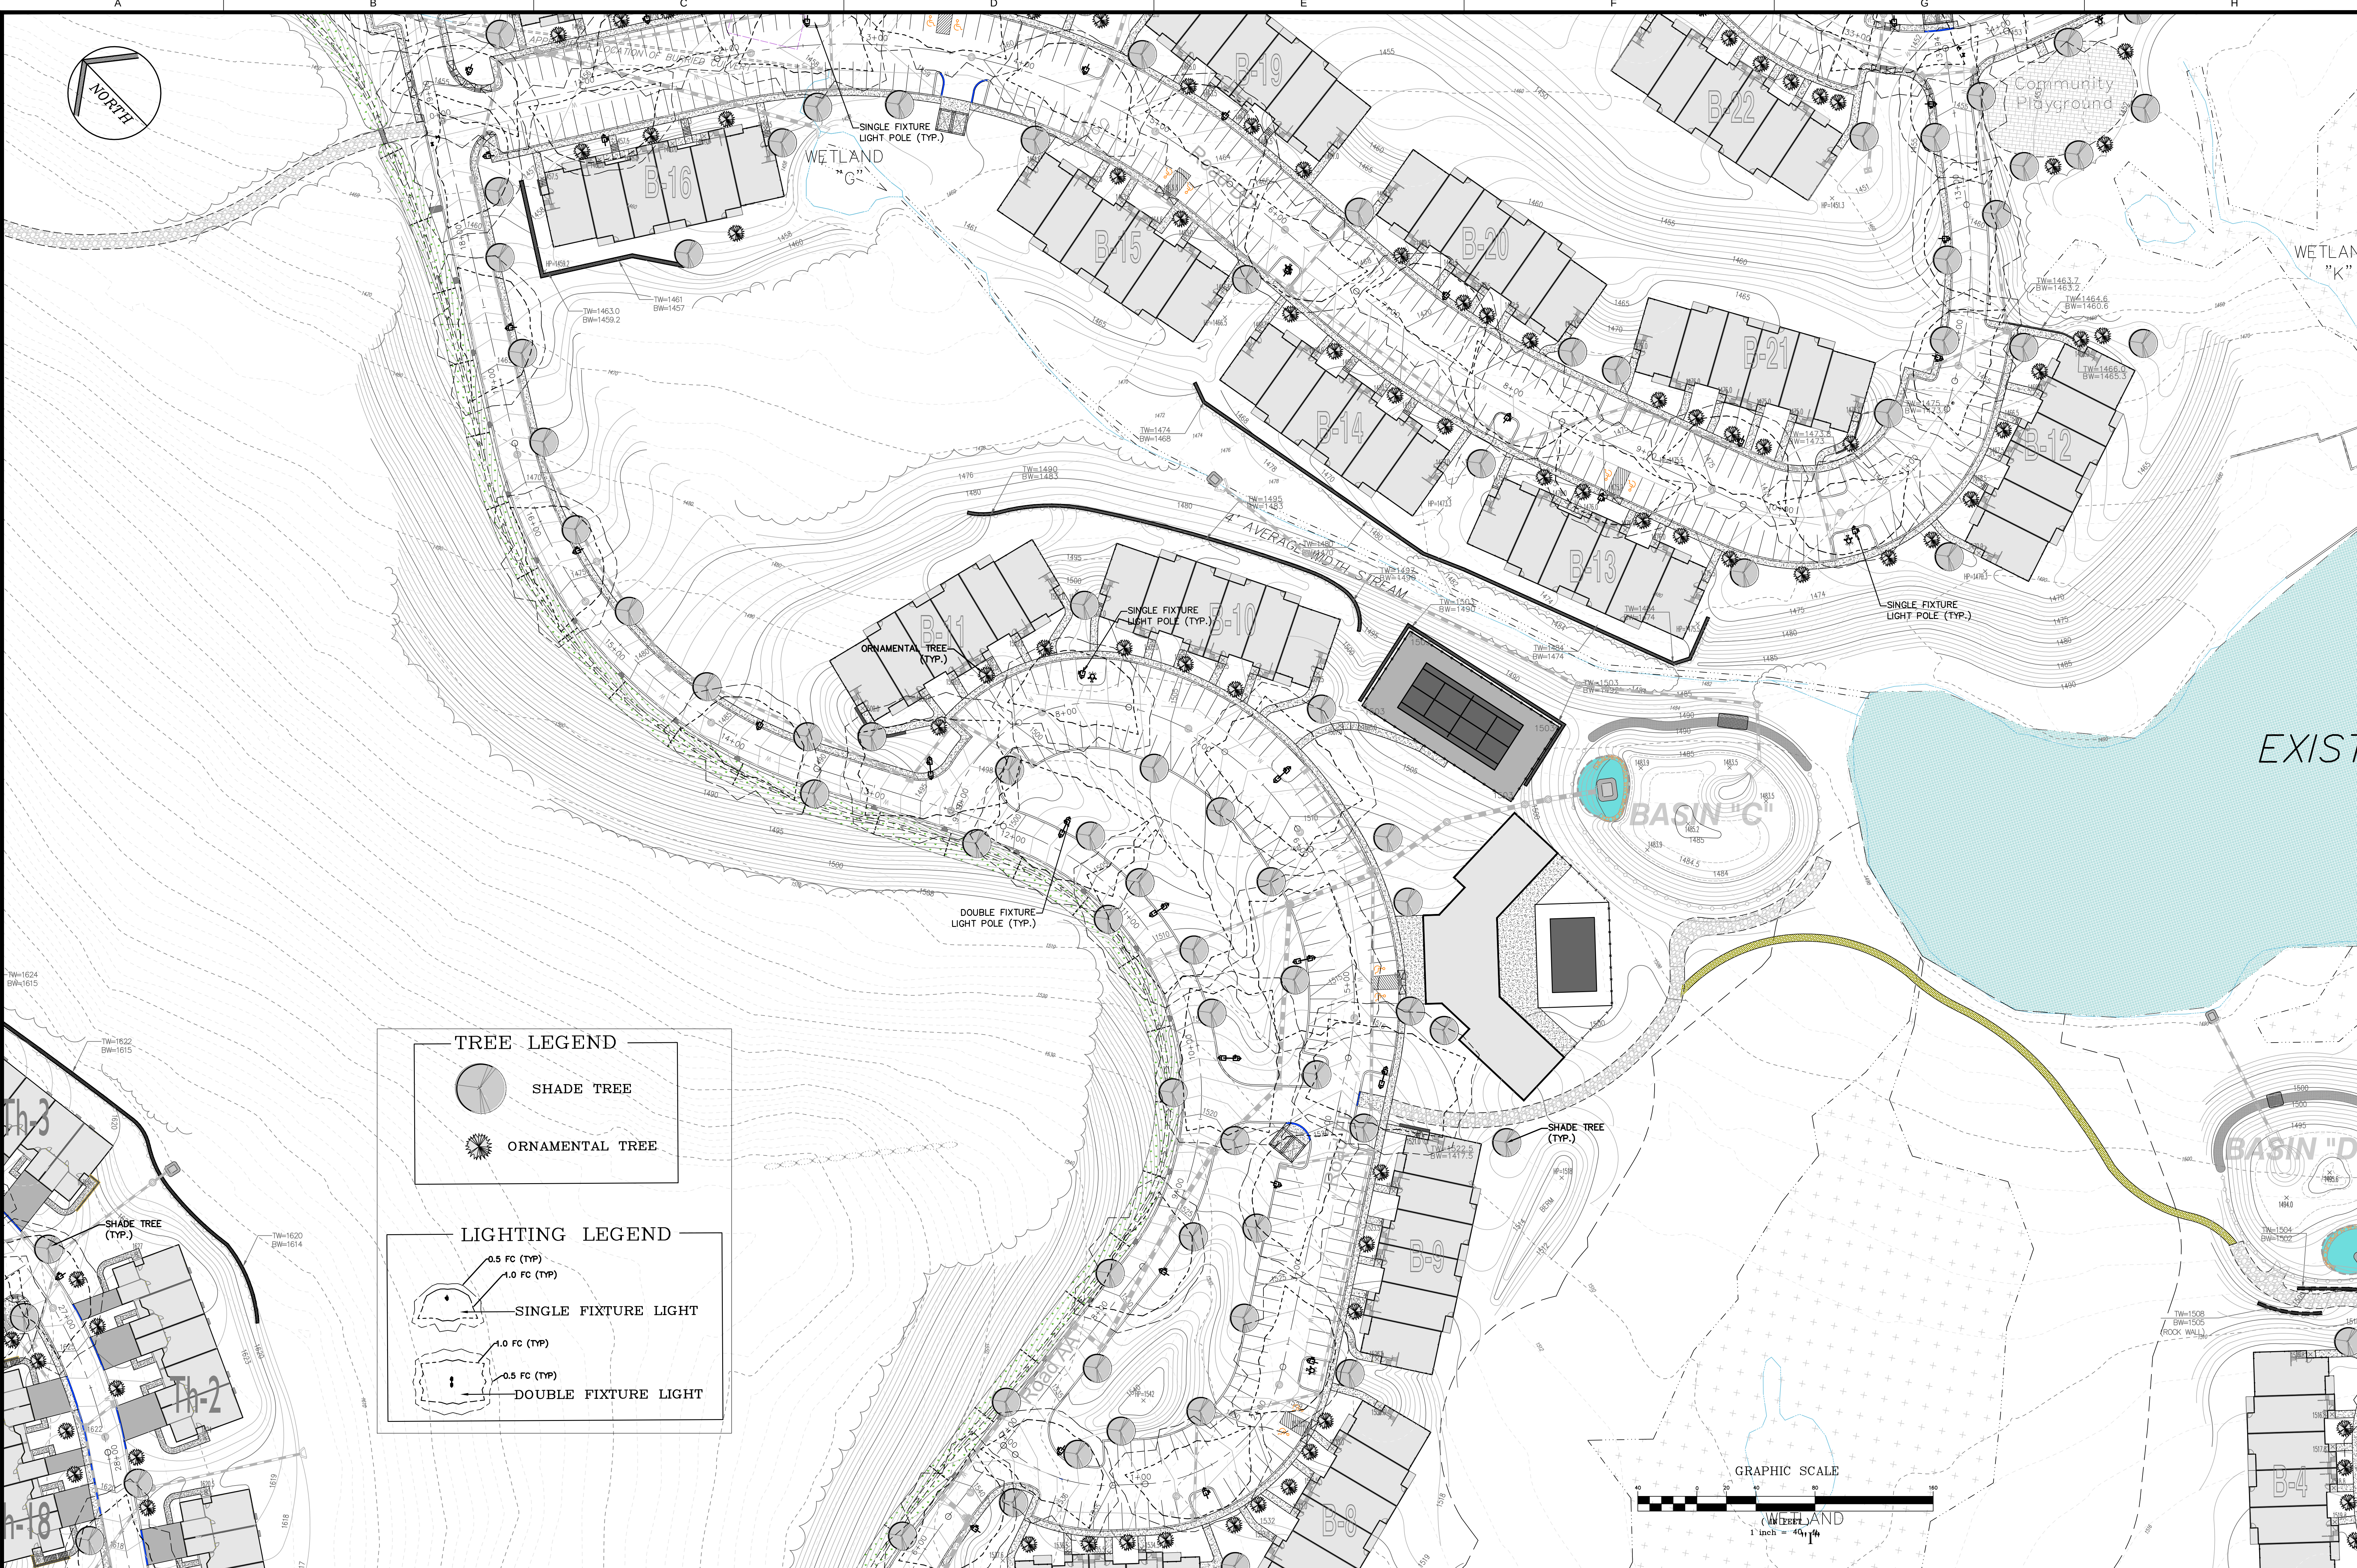

It is a violation of NYS Education Law, Article 145, Section 720(2)(b), for any person, firm or corporation to prepare, submit or use any drawing or plan for a project of construction or alteration of a building or structure, or any other project, without the seal and signature of a duly licensed professional engineer or architect. The seal and signature of the professional engineer or architect shall be placed on the drawing or plan in the right hand corner, and shall be legible and shall not be obscured by any other writing or mark. The seal and signature of the professional engineer or architect shall be placed on the drawing or plan in the right hand corner, and shall be legible and shall not be obscured by any other writing or mark. The seal and signature of the professional engineer or architect shall be placed on the drawing or plan in the right hand corner, and shall be legible and shall not be obscured by any other writing or mark.

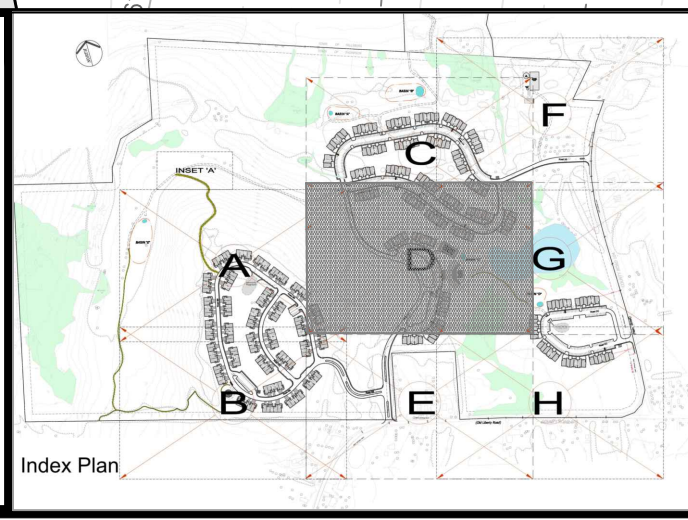

CONSULTANTS
PS&S
integrating design & engineering
67A MOUNTAIN BOULEVARD EXTENSION
P.O. BOX 4039
WARREN, NEW JERSEY 07059
PHONE: (732) 560-9700
FAX: (732) 560-9768

LISA A. DIGEROLAMO, P.E.
PROFESSIONAL ENGINEER
NEW YORK LIC. NO. 086749
SIGNATURE _____ DATE 7/1/2016

REVISIONS/ISSUES		
REV	DATE	DESCRIPTION
1	02/10/16	PRE-ISSUE FOR TEAM REVIEW
2	05/11/16	PRELIMINARY SITE PLAN REVIEW
3	07/5/16	SUBMISSION TO PLANNING BOARD

PROJECT TITLE
PRELIMINARY & FINAL SITE PLAN
Gan-Eden Estates
TOWN OF THOMPSON SULLIVAN COUNTY NEW YORK
TAX LOT
SECTION 2,
BLOCK 1/ LOT 6.3

SHEET TITLE
Landscaping & Lighting Plan
(Section D)

INITIAL DATE 12/04/2015	JOB NO. 01895/0053
SCALE 1"=40'	B/O
DRAWN CY/FM	SHEET NO.
CHKD. AG/LAD	C-7D 35 OF 79