


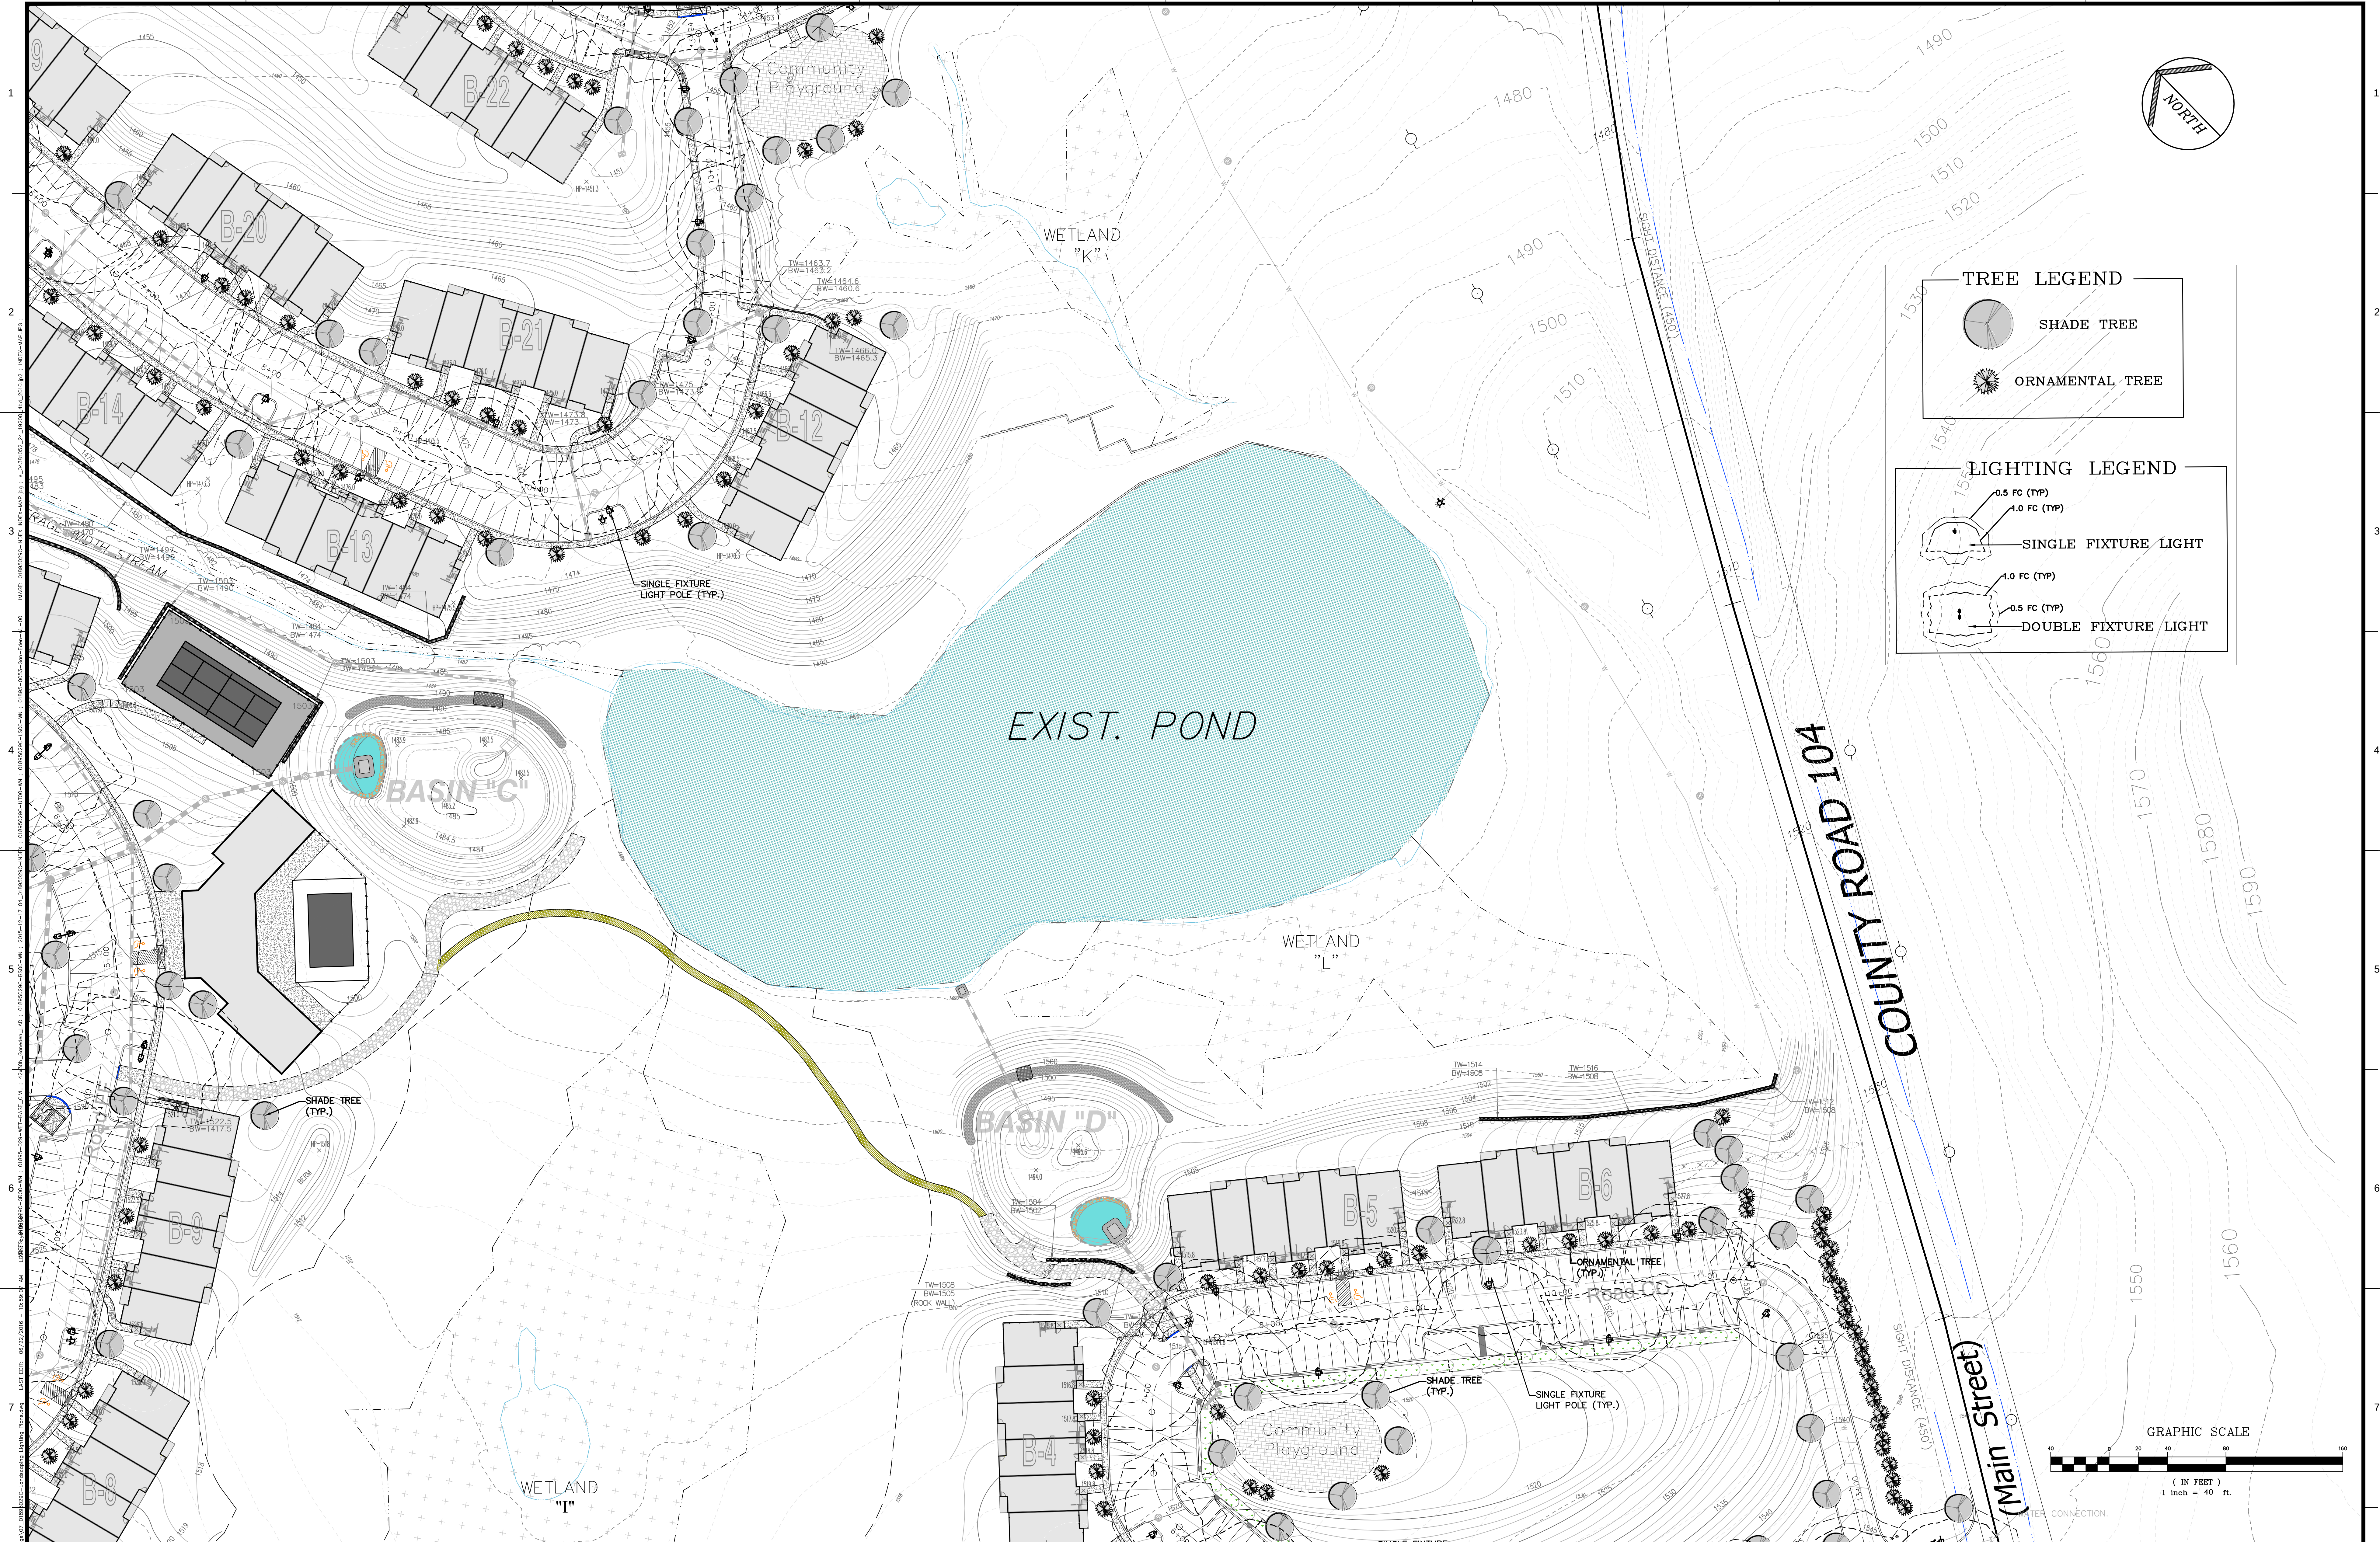

TREE LEGEND

SHADE TREE

ORNAMENTAL TREE

LIGHTING LEGEND

0.5 FC (TYP)
1.0 FC (TYP)
SINGLE FIXTURE LIGHT

1.0 FC (TYP)
0.5 FC (TYP)
DOUBLE FIXTURE LIGHT

It is the obligation of the Engineer to prepare the drawings in accordance with the provisions of the New York State Engineering Law, Article 145, Section 2208.2, for any project, unless he is advised by the client that the drawings are to be used for a purpose other than that intended by the Engineer. The Engineer shall not be responsible for any errors or omissions in the drawings or for any consequences arising therefrom, whether or not the drawings are used for a purpose other than that intended by the Engineer. The Engineer shall not be responsible for any errors or omissions in the drawings or for any consequences arising therefrom, whether or not the drawings are used for a purpose other than that intended by the Engineer.

ALL DIMENSIONS MUST BE NOTED BY THE CONTRACTOR. NOTIFY PAULUS, SCHOLONGSKI AND SARTOR OF ANY DIMENSIONS, TOLERANCES, OR DIMENSIONS IN THE CONTRACT. THESE DIMENSIONS SHALL BE AS NOTED IN WORDS OR NUMBERS ON THE CONTRACT. THESE DIMENSIONS SHALL BE AS NOTED IN WORDS OR NUMBERS ON THE CONTRACT. THESE DIMENSIONS SHALL BE AS NOTED IN WORDS OR NUMBERS ON THE CONTRACT.

THE CONTRACTOR SHALL BE RESPONSIBLE FOR OBTAINING ALL NECESSARY PERMITS AND APPROVALS FROM THE APPROPRIATE AGENCIES. THE CONTRACTOR SHALL BE RESPONSIBLE FOR OBTAINING ALL NECESSARY PERMITS AND APPROVALS FROM THE APPROPRIATE AGENCIES. THE CONTRACTOR SHALL BE RESPONSIBLE FOR OBTAINING ALL NECESSARY PERMITS AND APPROVALS FROM THE APPROPRIATE AGENCIES.

THE CONTRACTOR SHALL BE RESPONSIBLE FOR OBTAINING ALL NECESSARY PERMITS AND APPROVALS FROM THE APPROPRIATE AGENCIES. THE CONTRACTOR SHALL BE RESPONSIBLE FOR OBTAINING ALL NECESSARY PERMITS AND APPROVALS FROM THE APPROPRIATE AGENCIES. THE CONTRACTOR SHALL BE RESPONSIBLE FOR OBTAINING ALL NECESSARY PERMITS AND APPROVALS FROM THE APPROPRIATE AGENCIES.

INDEX PLAN

CONSULTANTS

PS&S
integrating design & engineering

67A MOUNTAIN BOULEVARD EXTENSION
P.O. BOX 4039
WARREN, NEW JERSEY 07059
PHONE: (732) 560-9700
FAX: (732) 560-9768

LISA A. DIGEROLAMO, P.E.
PROFESSIONAL ENGINEER
NEW YORK LIC. NO. 086749

SIGNATURE _____ DATE 7/1/2016

REV	DATE	DESCRIPTION
1	02/10/16	PRE-ISSUE FOR TEAM REVIEW
2	05/11/16	PRELIMINARY SITE PLAN REVIEW
3	07/5/16	SUBMISSION TO PLANNING BOARD

PROJECT TITLE

PRELIMINARY & FINAL SITE PLAN

Gan-Eden Estates

TOWN OF THOMPSON SULLIVAN COUNTY NEW YORK

TAX LOT SECTION 2, BLOCK 1/ LOT 6.3

SHEET TITLE

Landscaping & Lighting Plan
(Section G)

INITIAL DATE	12/04/2015	JOB NO.	01895/0053
SCALE	1"=40'	B/O	
DRAWN	CY/FM	SHEET NO.	C-7G
CHKD.	AG/LAD		38 OF 79