


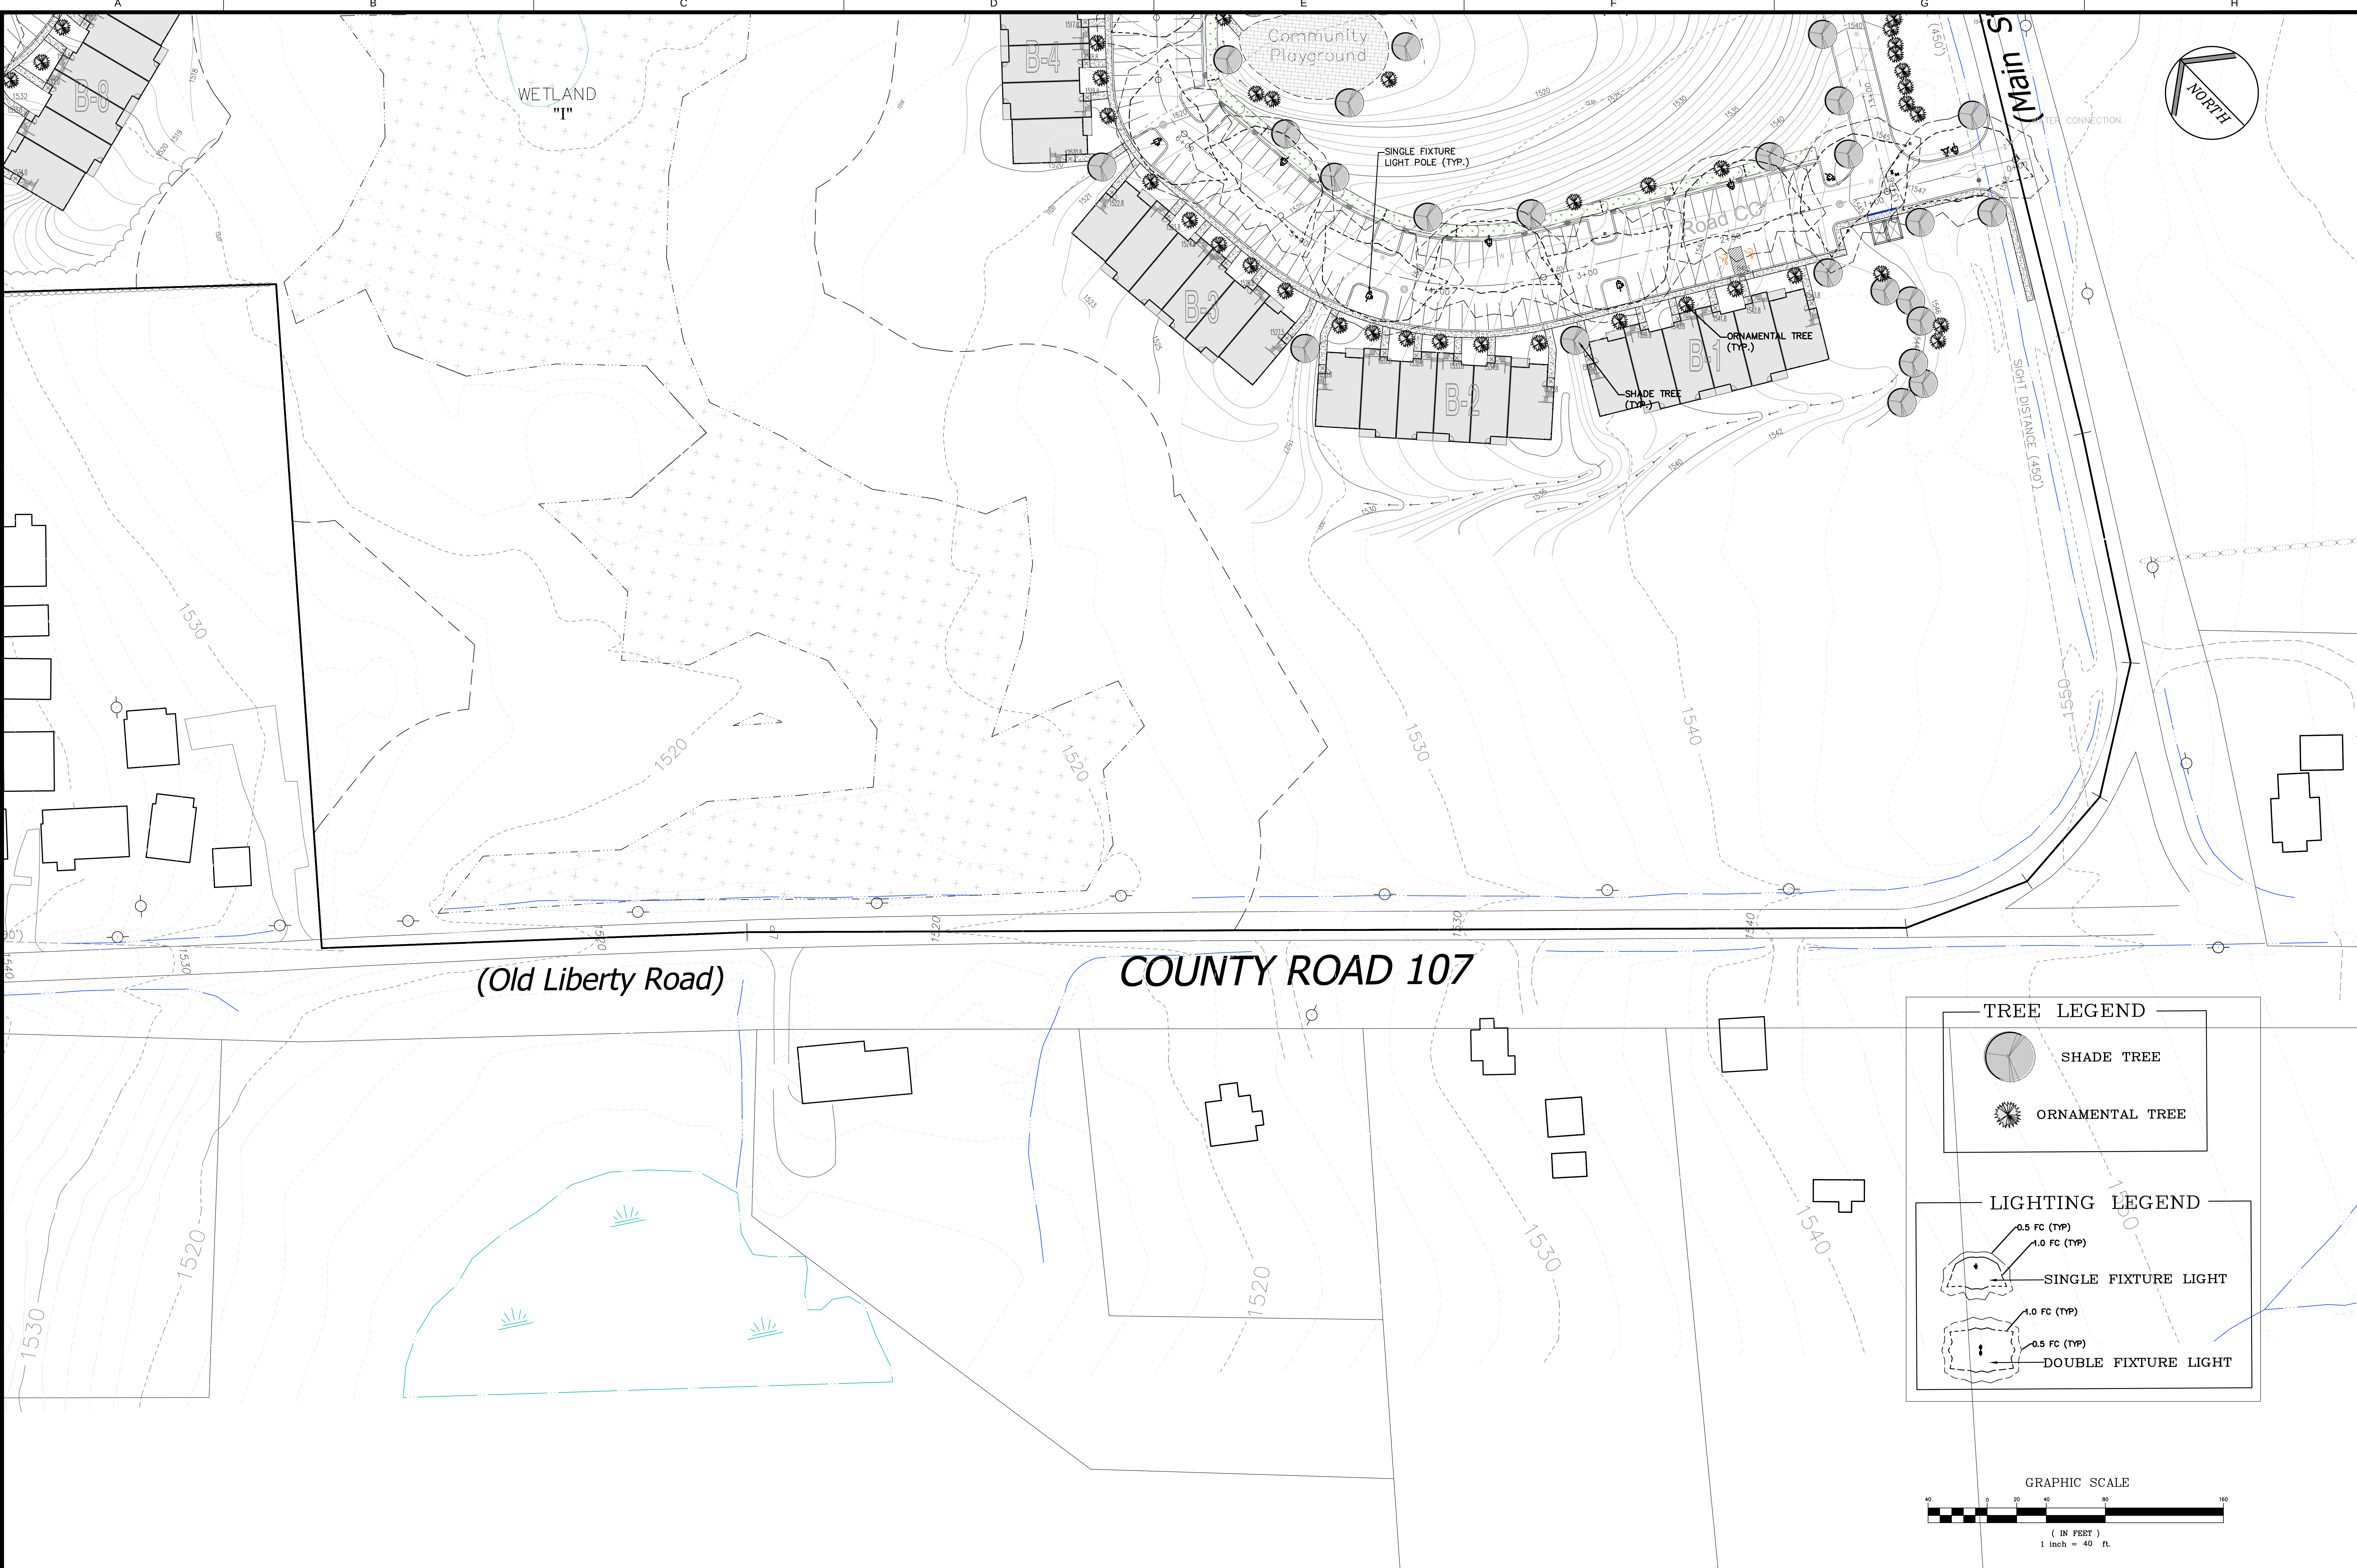

It is the obligation of the Engineer to provide a clear and concise set of drawings for the project. The drawings shall be prepared in accordance with the requirements of the applicable codes and standards. The drawings shall be prepared in a clear and concise manner, and shall be submitted to the appropriate authorities for review and approval. The drawings shall be prepared in a clear and concise manner, and shall be submitted to the appropriate authorities for review and approval.

CONSULTANTS

PS&S
integrating design & engineering

67A MOUNTAIN BOULEVARD EXTENSION
P.O. BOX 4039
WARREN, NEW JERSEY 07059
PHONE: (732) 560-9700
FAX: (732) 560-9768

LISA A. DIGEROLAMO, P.E.
PROFESSIONAL ENGINEER
NEW YORK LIC. NO. 086749

SIGNATURE _____ DATE 7/1/2016

REVISIONS/ISSUES		
REV	DATE	DESCRIPTION
1	02/10/16	PRE-ISSUE FOR TEAM REVIEW
2	05/11/16	PRELIMINARY SITE PLAN REVIEW
3	07/5/16	SUBMISSION TO PLANNING BOARD

PROJECT TITLE

PRELIMINARY & FINAL SITE PLAN

Gan-Eden Estates

TOWN OF THOMPSON SULLIVAN COUNTY NEW YORK

TAX LOT SECTION 2, BLOCK 1/ LOT 6.3

SHEET TITLE

Landscaping & Lighting Plan
(Section H)

INITIAL DATE	12/04/2015	JOB NO.	01895/0053
SCALE	1"=40'	B/O	
DRAWN	CY/FM	SHEET NO.	C-7H
CHKD.	AG/LAD		39 OF 79